



LEGEND:	
	REMOVE EXISTING DUPLEX OUTLET
	REMOVE EXISTING QUADPLEX OUTLET
	EXISTING BLANK FACEPLATE
	DEMO VOICE/DATA
	REMOVE AND RELOCATE SECURITY PANIC BUTTON
	REMOVE AND RELOCATE SECURITY CARD SWIPE
	EXISTING LIGHT SWITCH TO REMAIN
	INSTALL NEW DUPLEX OUTLET
	INSTALL NEW QUADPLEX OUTLET
	INSTALL NEW VOICE/DATA OUTLET
	INSTALL NEW FLOOR MOUNT QUADPLEX OUTLETS AND CAT5 VOICE/DATA OUTLET
	INSTALL NEW FLOOR MOUNT DUPLEX OUTLETS AND CAT5 VOICE/DATA OUTLET
	INSTALL NEW COAX CABLE OUTLET
NOTES:	
1.	ALL VOICE/DATA TO TERMINATE @ TELCO ROOM AND TO BE CLEARLY MARKED WITH LABEL AND TESTED. OWNER TO IDENTIFY TELECO LOCATION.
2.	ALL VOICE/DATA TO BE HOUSED IN 1" CONDUIT.
3.	DASHED LINES ARE ITEMS TO BE REMOVED, SOLID LINES WITH "N" ARE NEW AND NON-IDENTIFIED SOLID LINES EXISTING TO REMAIN.
4.	DIMENSION LINES TO CENTER OF BOX.

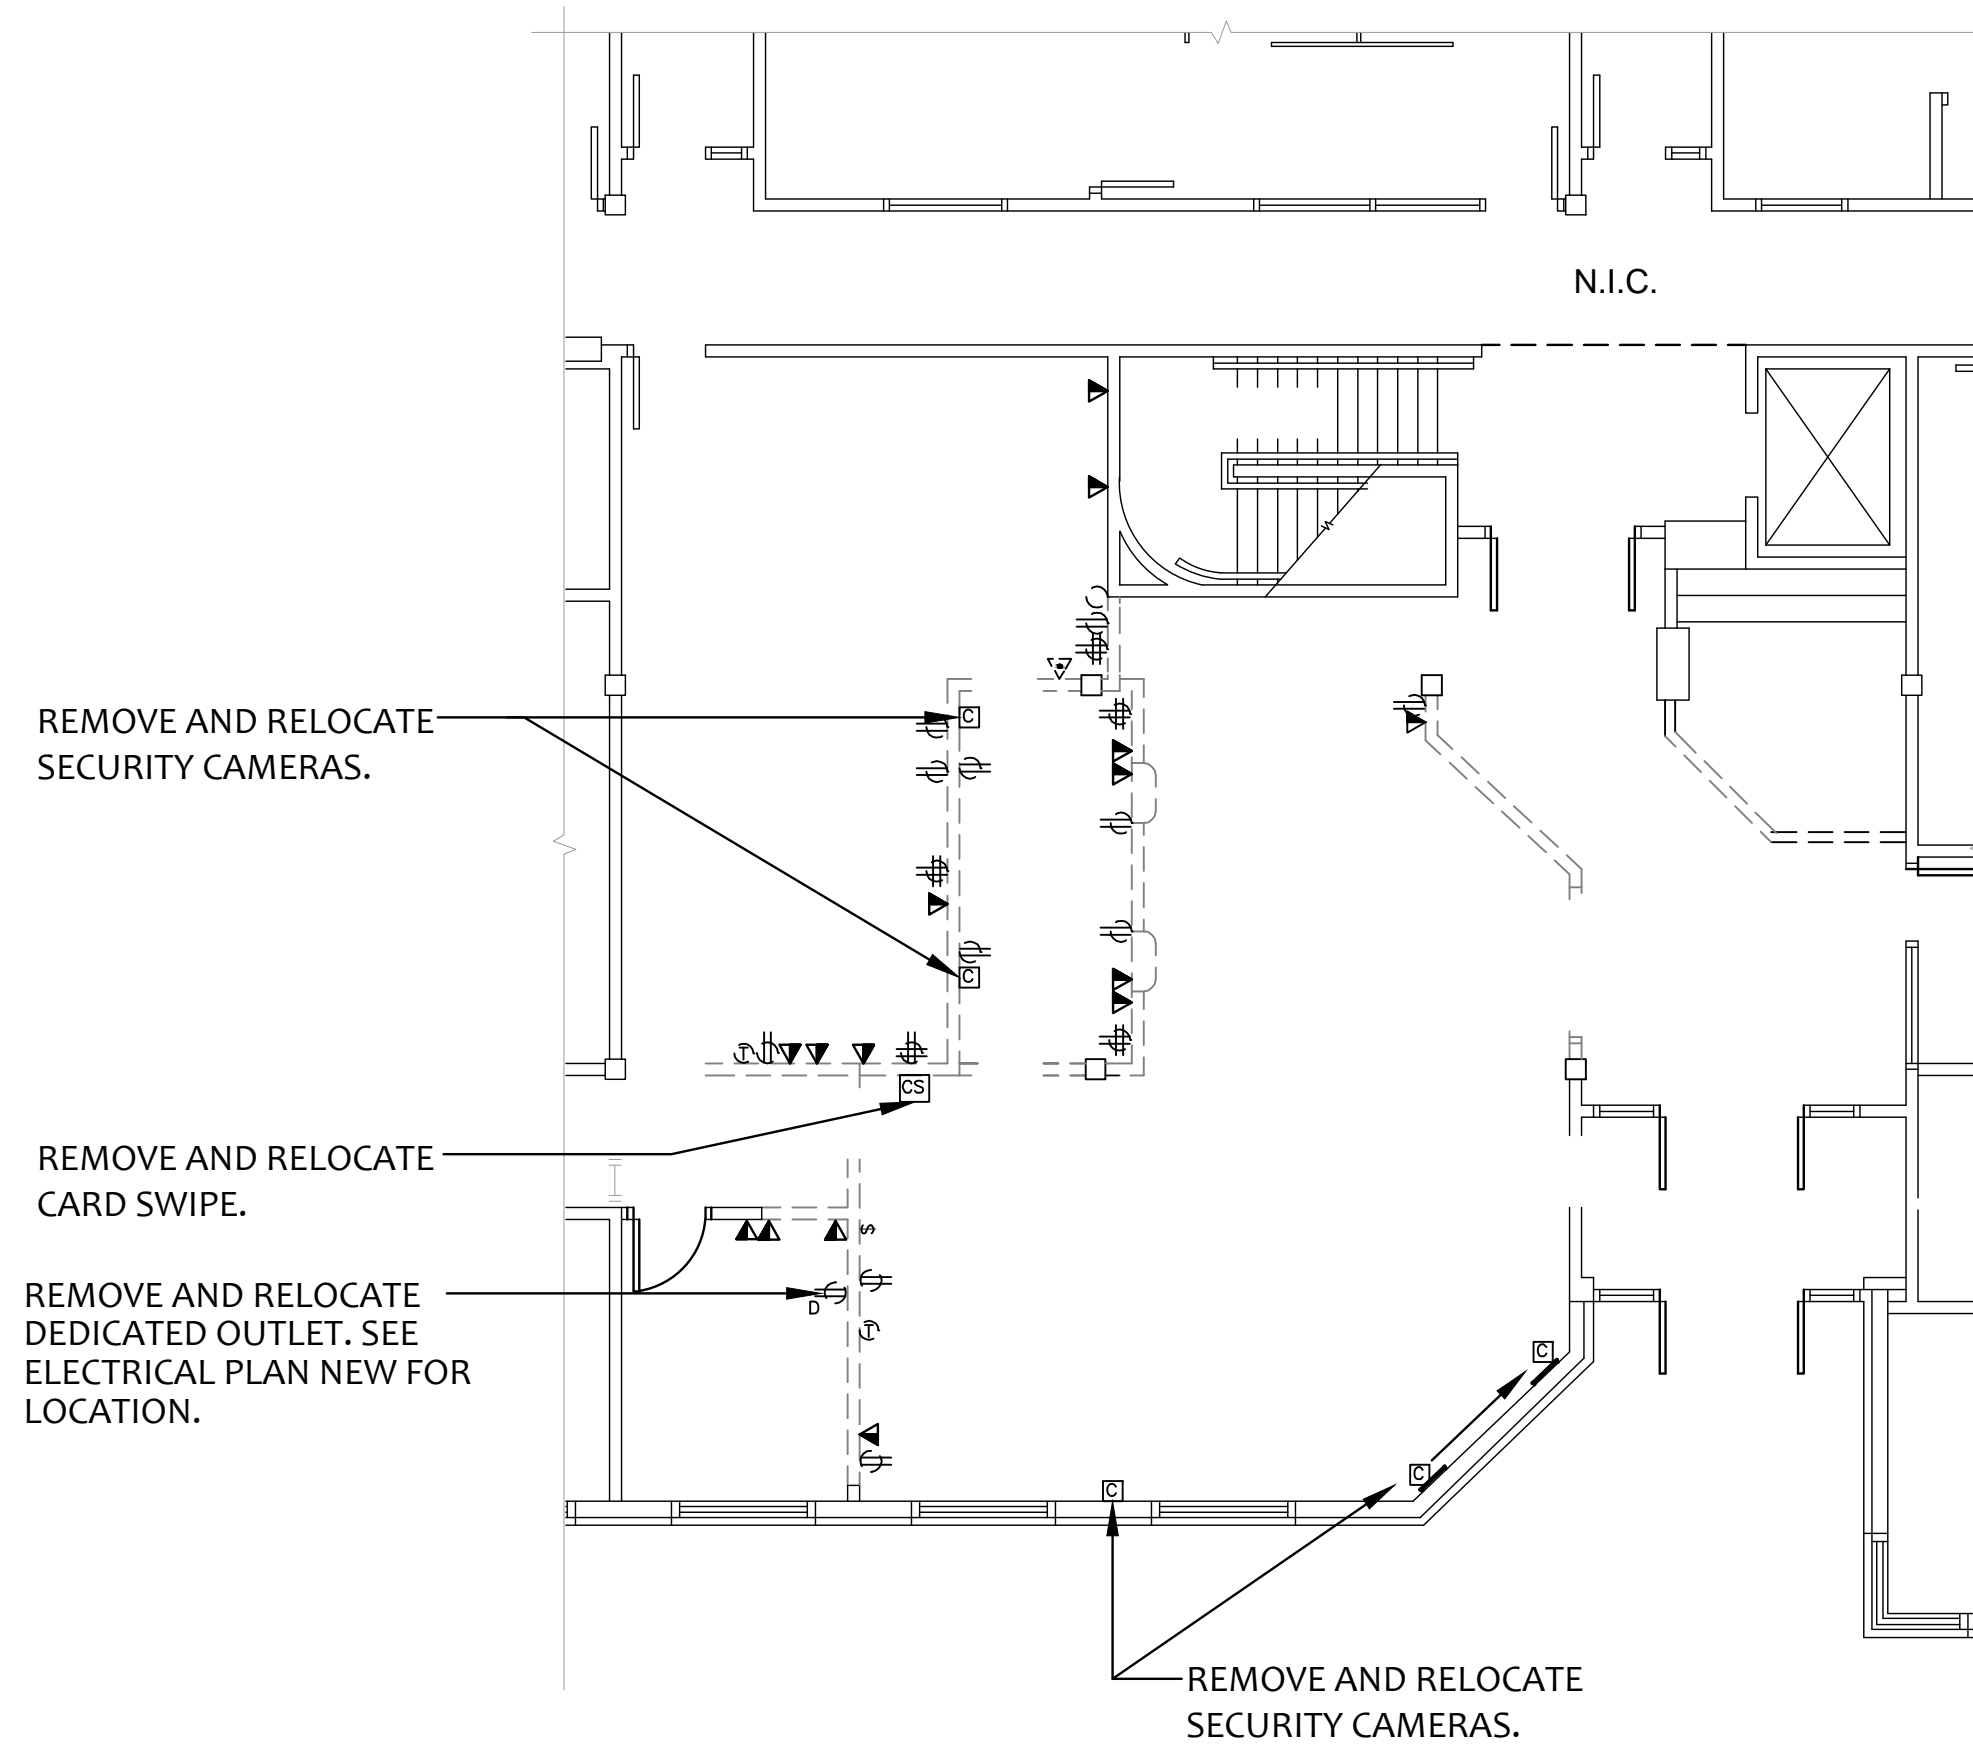


ELECTRICAL PLAN - DEMOLITION

SCALE: 1/8" - 1'-0"

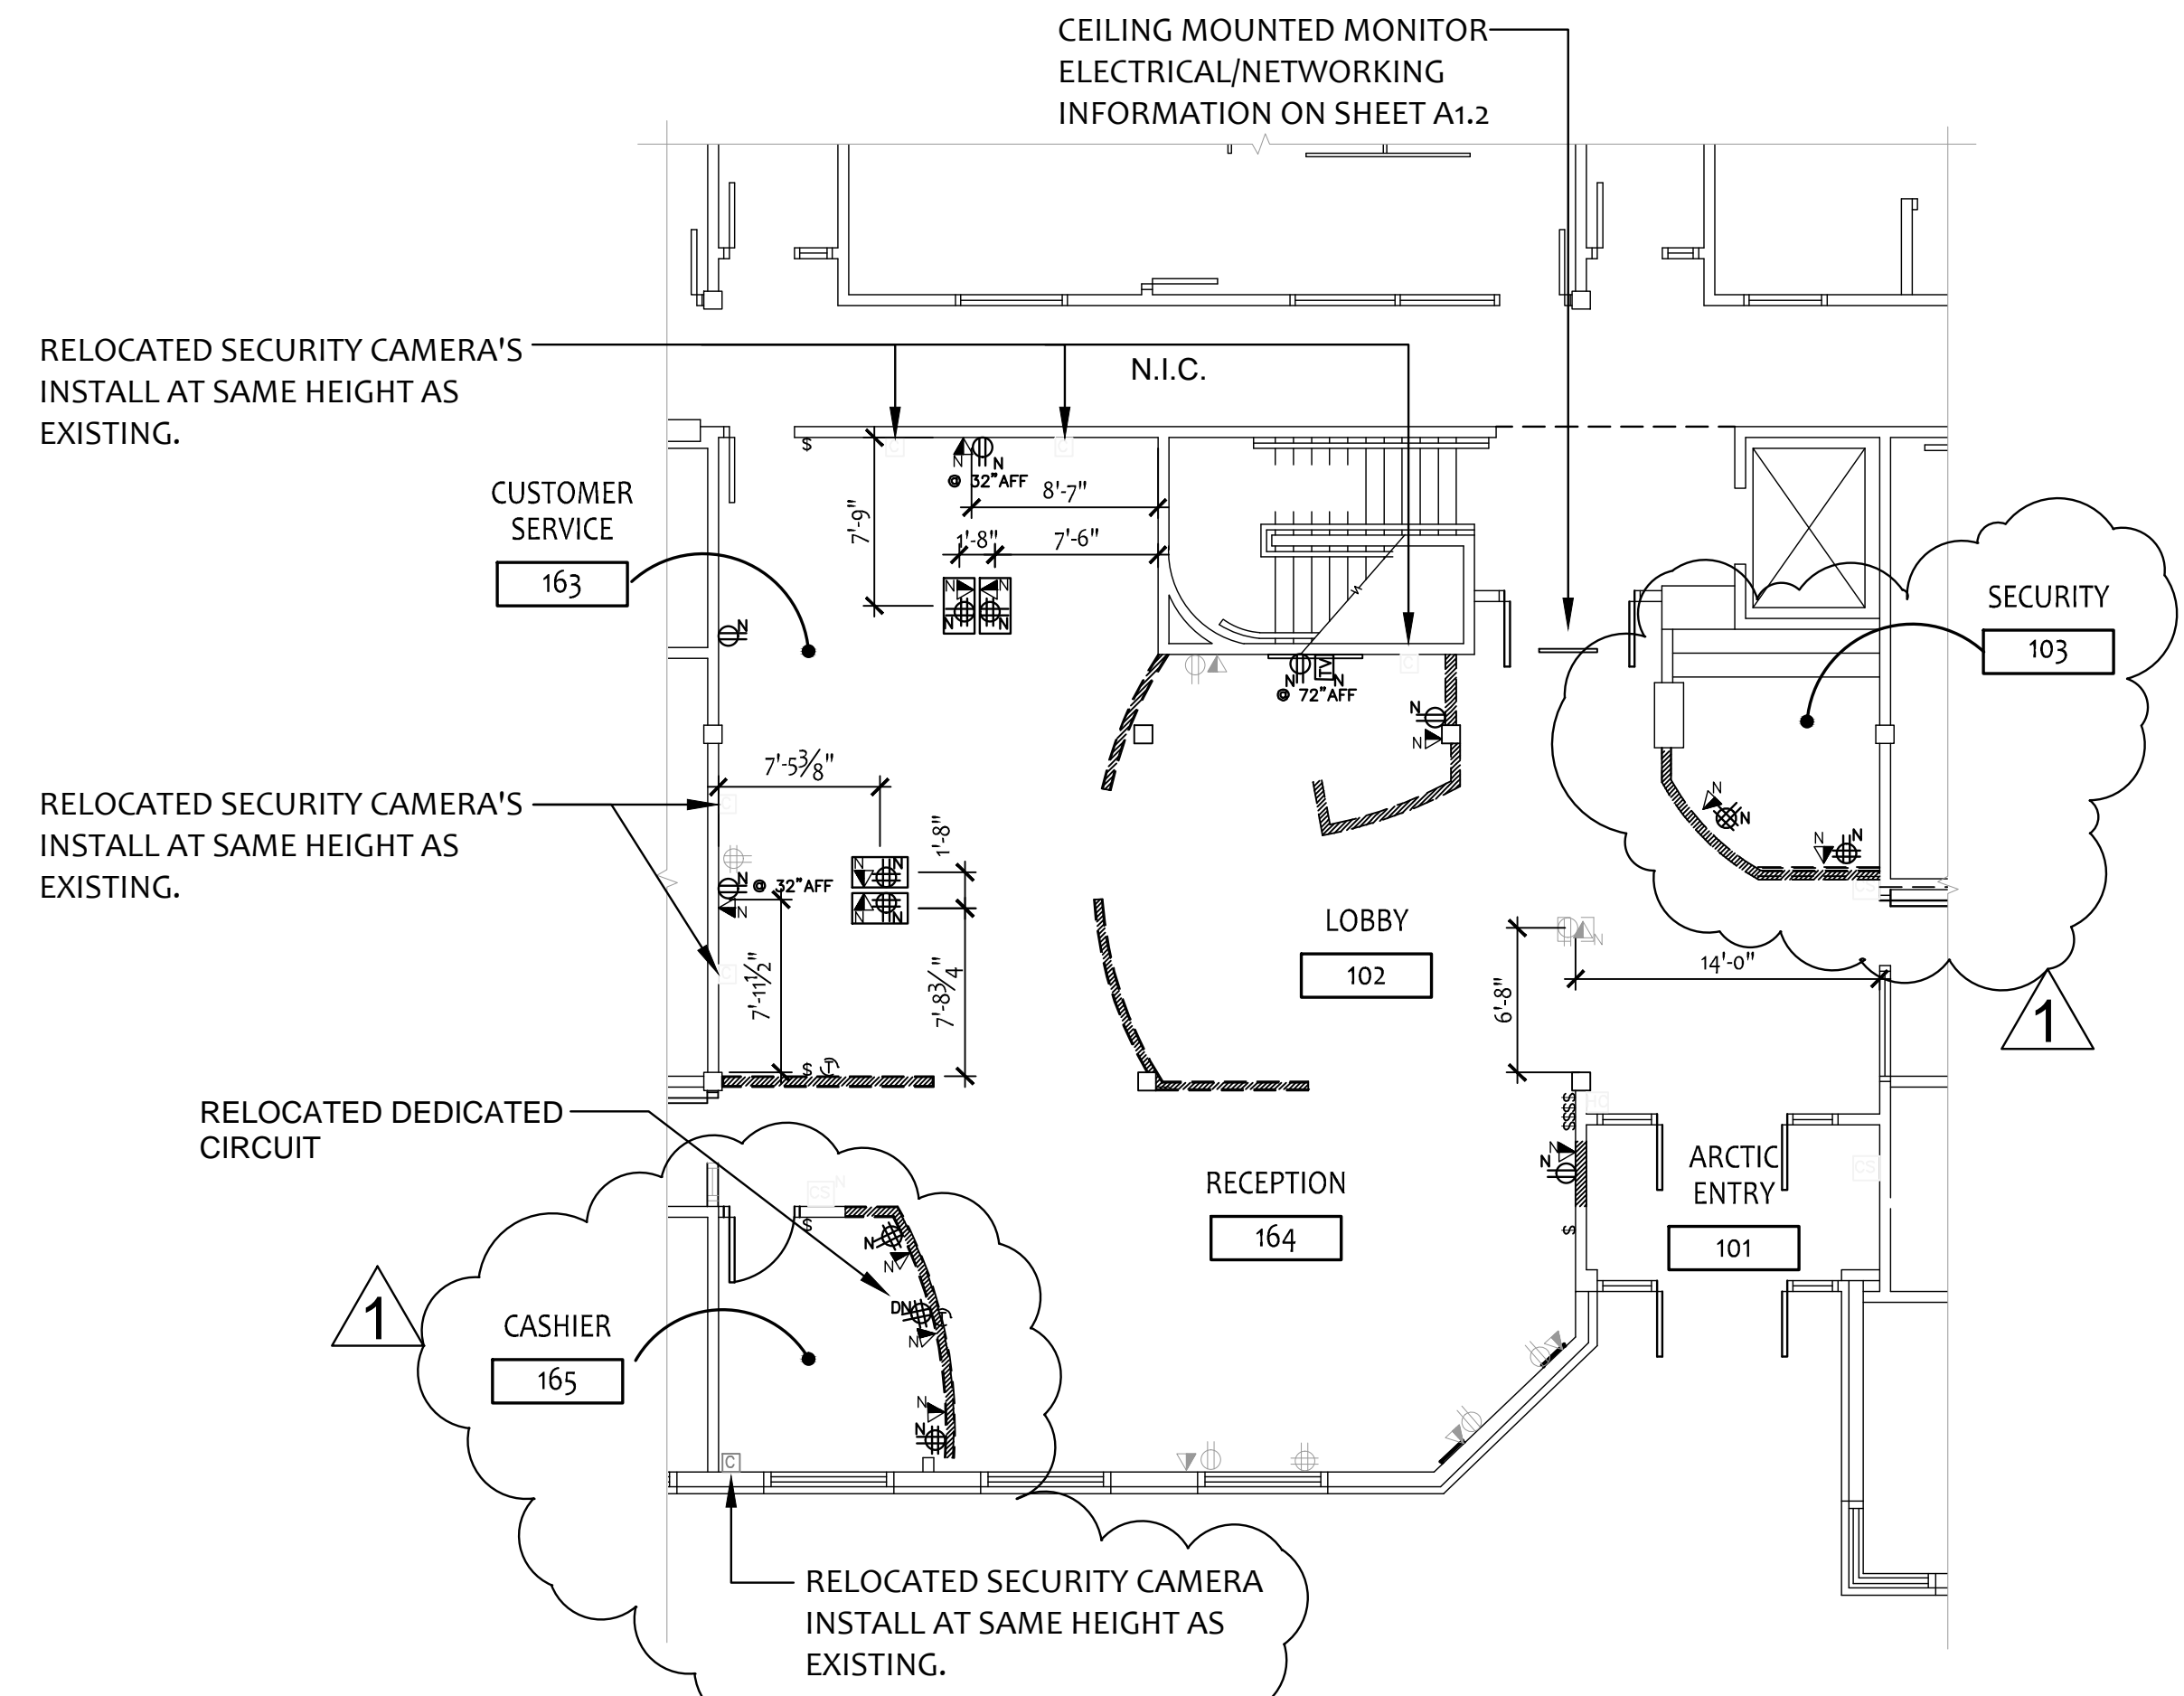

ELECTRICAL PLAN - NEW

SCALE: 1/8" - 1'-0"

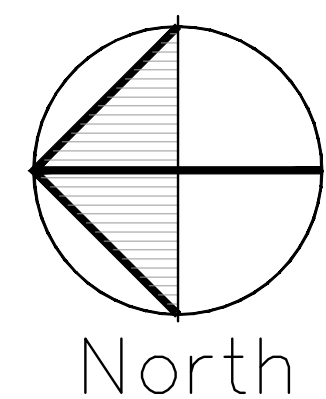

DRAWN BY: JLV
CHECKED: XXX
JOB NO: 09-023
DATE: 21JAN2010
SCALE: 1/8" - 1'-0"

REVISIONS:
1 03FEB2010

SHEET NO:
A1.1